

BUILDING 775 PARKING IMPROVEMENTS TEXAS A&M UNIVERSITY

ELECTRICAL SHEET INDEX - TRC

	Sheet No.
CABLE ROUTE & EQUIPMENT DRAWING	SHEET 1 OF 1
CPS METER AND SERVICE GUIDE	SHEET 1 OF 2
CPS METER AND SERVICE GUIDE	SHEET 2 OF 2
TRENCH DETAILS	SHEET 1 OF 1
TYPICAL TRENCH DETAILS FOR PARKING LOT OR STREET	SHEET 1 OF 1
SECONDARY ENCLOSURE DETAILS	SHEET 1 OF 3
SECONDARY ENCLOSURE DETAILS	SHEET 2 OF 3
SECONDARY ENCLOSURE DETAILS	SHEET 3 OF 3


*SITE LIGHTING SHEET INDEX - TBG

	Sheet No.
LIGHTING PLAN (SEE NOTE BELOW. SHEET PROVIDED FOR REF. ONLY)	LL 1.1
LIGHTING DETAILS	LL 2.1

NOTE: * REFERENCE TBG PLANS FOR FIXTURE LOCATIONS & FOUNDATION DESIGN ONLY. REFERENCE SHEETS C2.00 & C2.01 FOR ACTUAL PROJECT LIMITS & FIXTURES TO BE INSTALLED WITH THIS CONTRACT. LIGHT POLE & FIXTURE SPECIFICATIONS ARE INCLUDED IN QUANTITY LIST & PROJECT SPECIFICATIONS.

CIVIL SHEET INDEX - PAPE DAWSON ENGINEERS

Description	
COVER SHEET	C1.00
DIMENSIONAL CONTROL AND PAVING PLAN	C2.00
SITE DETAILS	C2.01

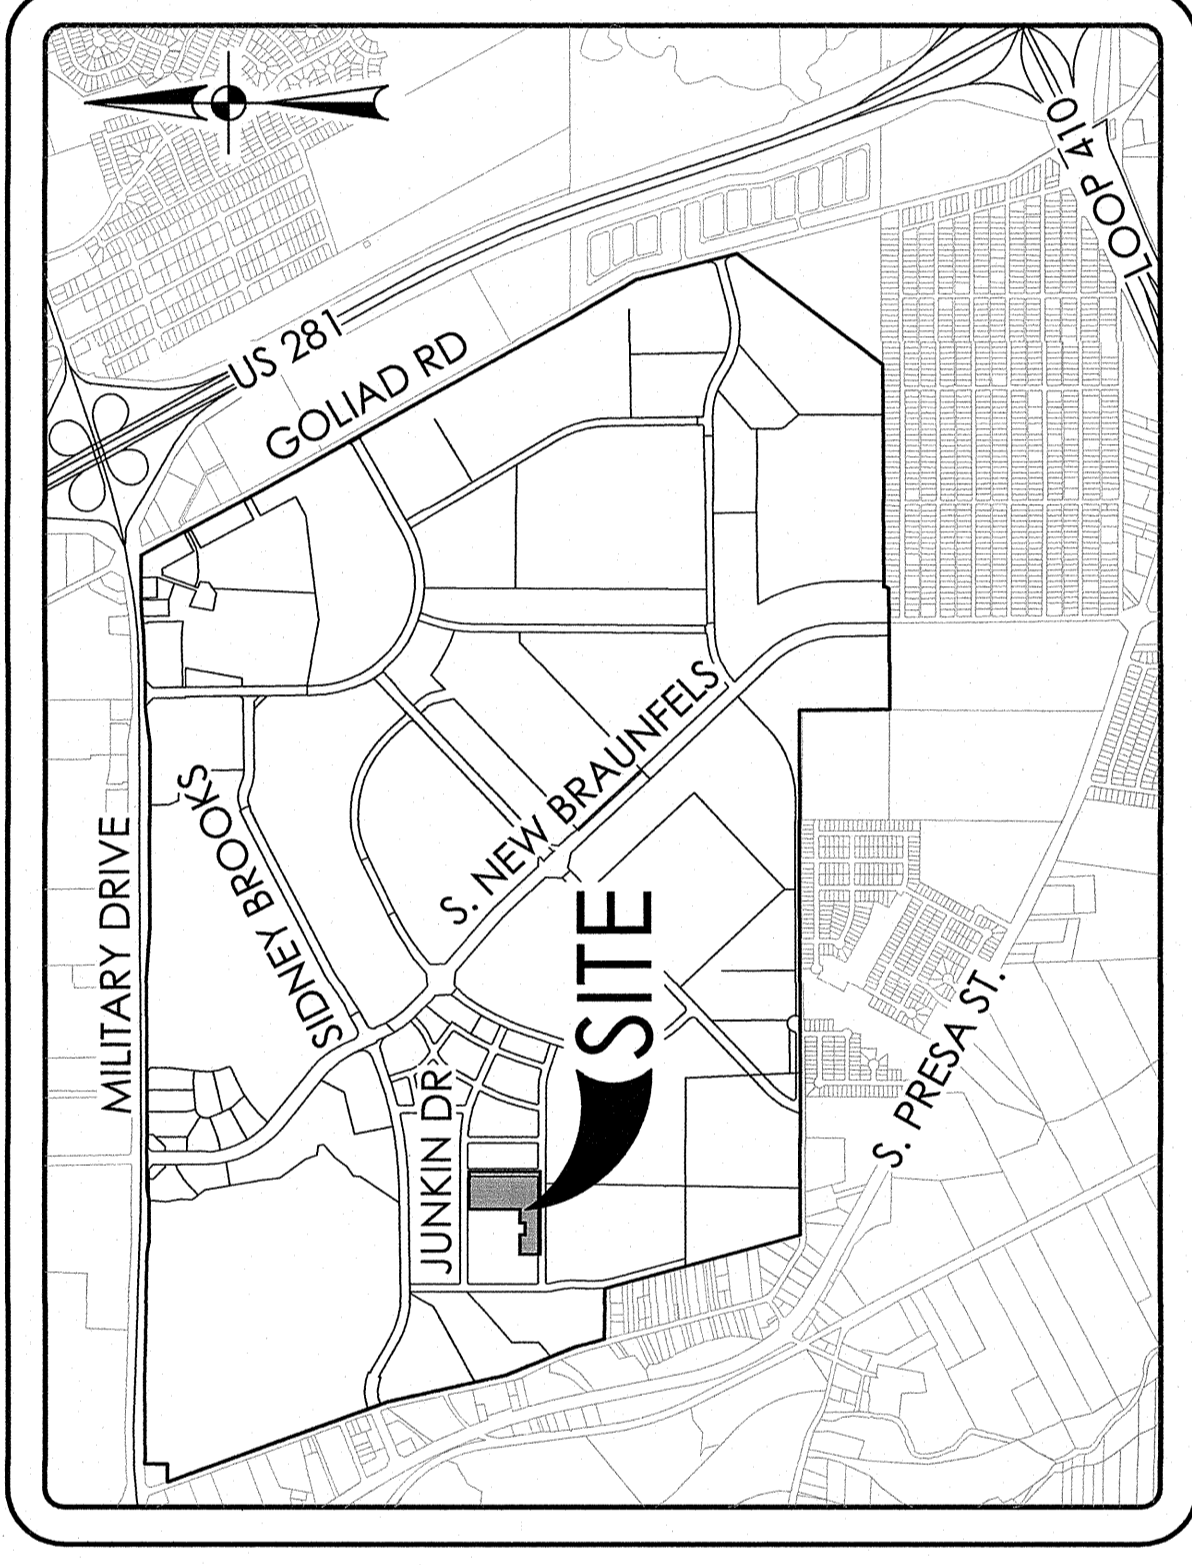

LOCATION MAP

NOT-TO-SCALE

BROOKS DEVELOPMENT AUTHORITY
3201 SIDNEY BROOKS, BLDG 502
SAN ANTONIO, TEXAS 78235

FEBRUARY 2013



555 EAST RAMSEY | SAN ANTONIO, TEXAS 78216 | PHONE: 214.375.9000
FAC: 214.375.9610
TEXAS BOARD OF PROFESSIONAL ENGINEERS, P.E. REGISTRATION # 470

