



Brooks Development Authority
Hangar 9 Restoration

Bid # 12072015-003
Addendum: Landscape Irrigation Requirements

Sheets L2.0 and L2.1

Add Central control modules to relocated Hunter ACC irrigation controllers relocated with Hangar 9 Historic Restoration project.


Install in relocated Brooks Gravesite controller Hunter ACC-COM-LAN module, and Hunter ACC/HWIM Hardware Interface Module.

Install in New Braunfels Road relocated controller Hunter ACC-COM-HWR module, and Hunter ACC/HWIM Hardware Interface Module.

Programming and connections will be made by client.

System shall be setup such that the relocated Brooks Gravesite controller functions as the primary control unit, and the New Braunfels Road relocated controller as a satellite unit (HWR module), hardwired into the Gravesite controller (LAN module).



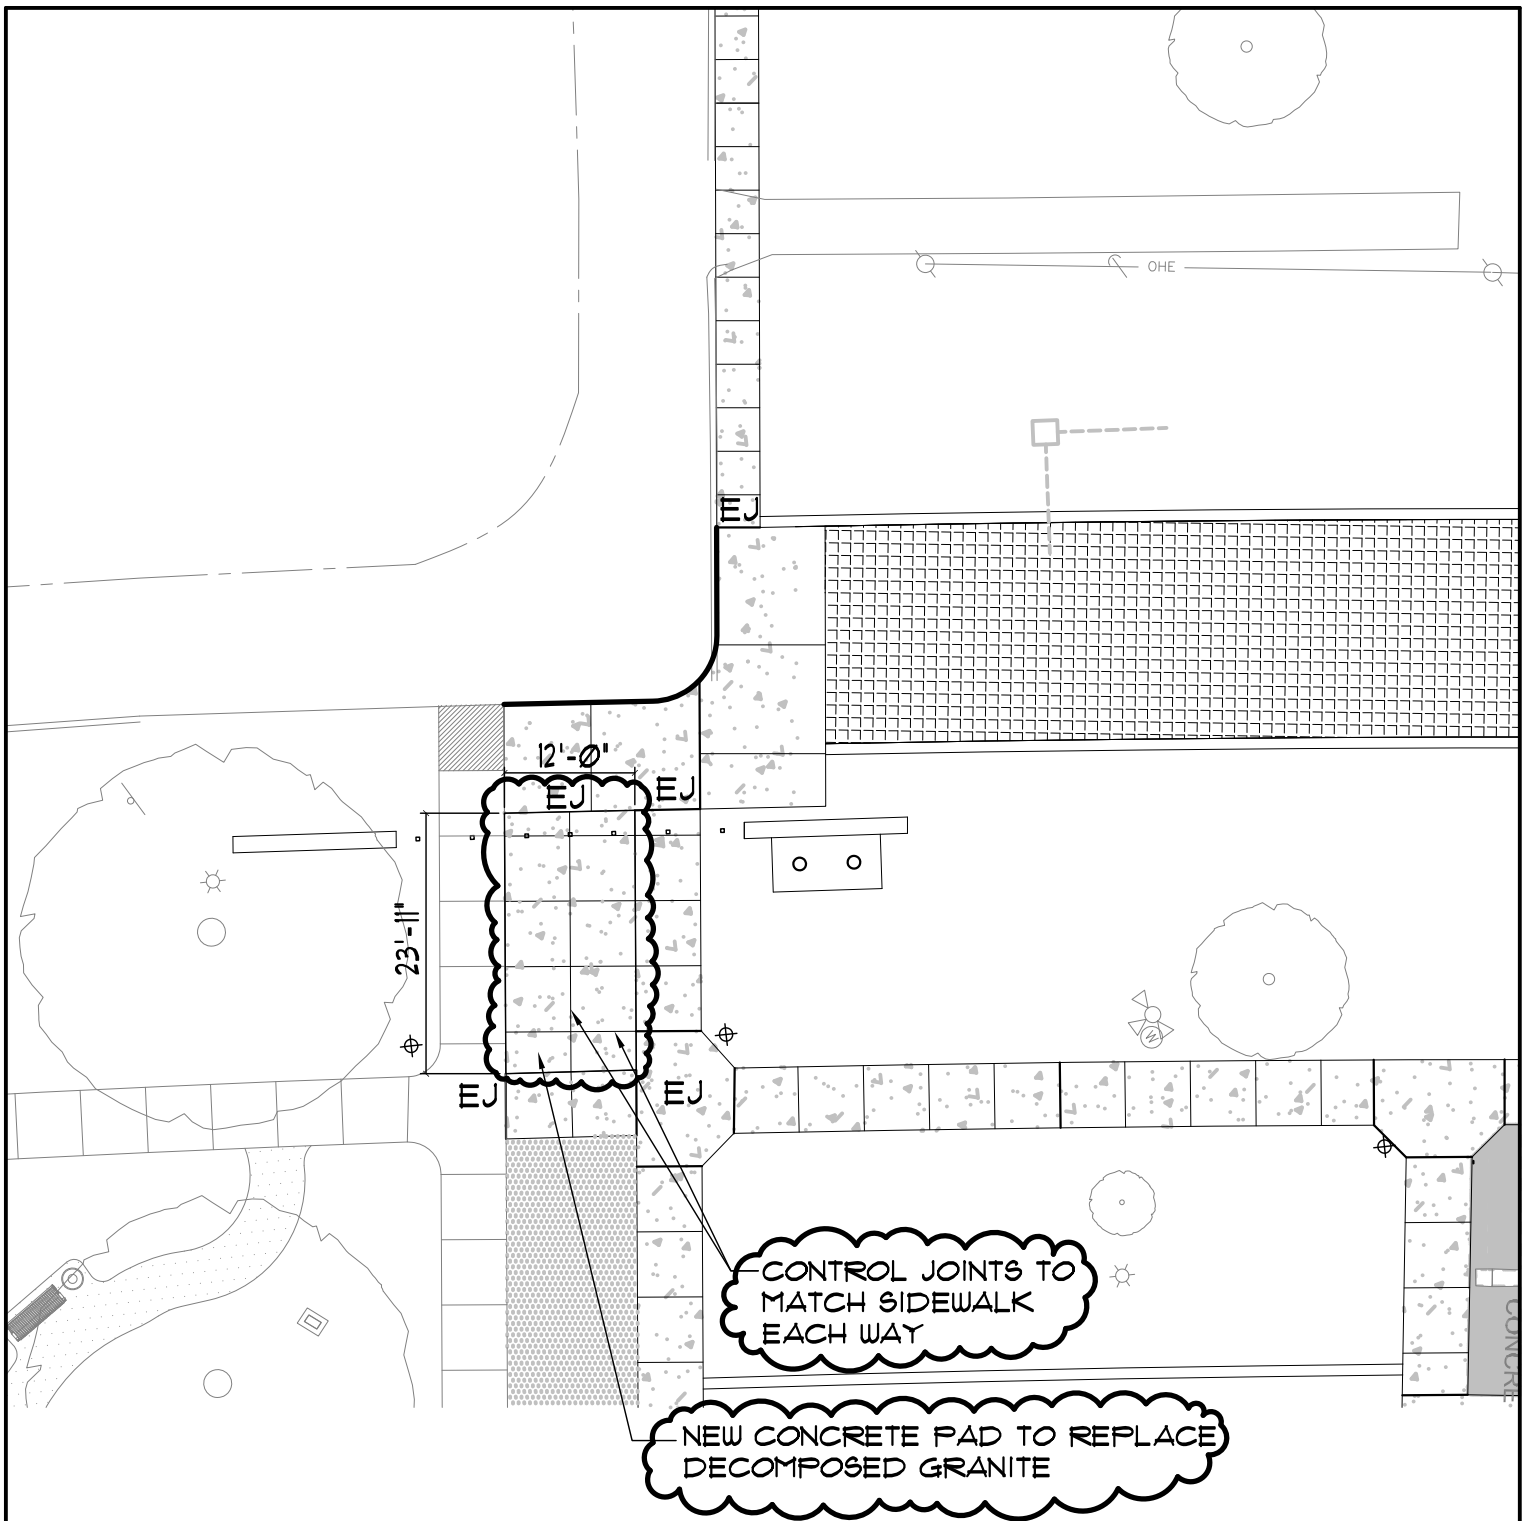


01 ENLARGED SITE PLAN
SCALE N.T.S.




Plan North



True North

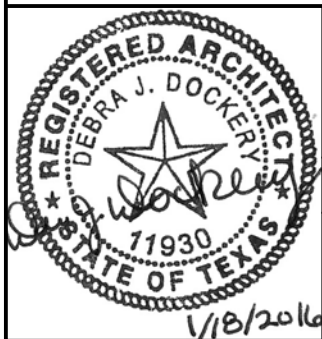


REFERENCE: ADDENDUM #2	SHEET # 1 OF 1	DATE: 01-18-2016
HANGER 9 HISTORICAL RESTORATION	Debra J. Dockery, Architect, P.C.	
BROOKS CITY BASE PROJECT NO. 15-01	118 BROADWAY, SUITE 516 PHONE (210) 225-6130	SAN ANTONIO, TX 78205 FAX (210) 225-7588

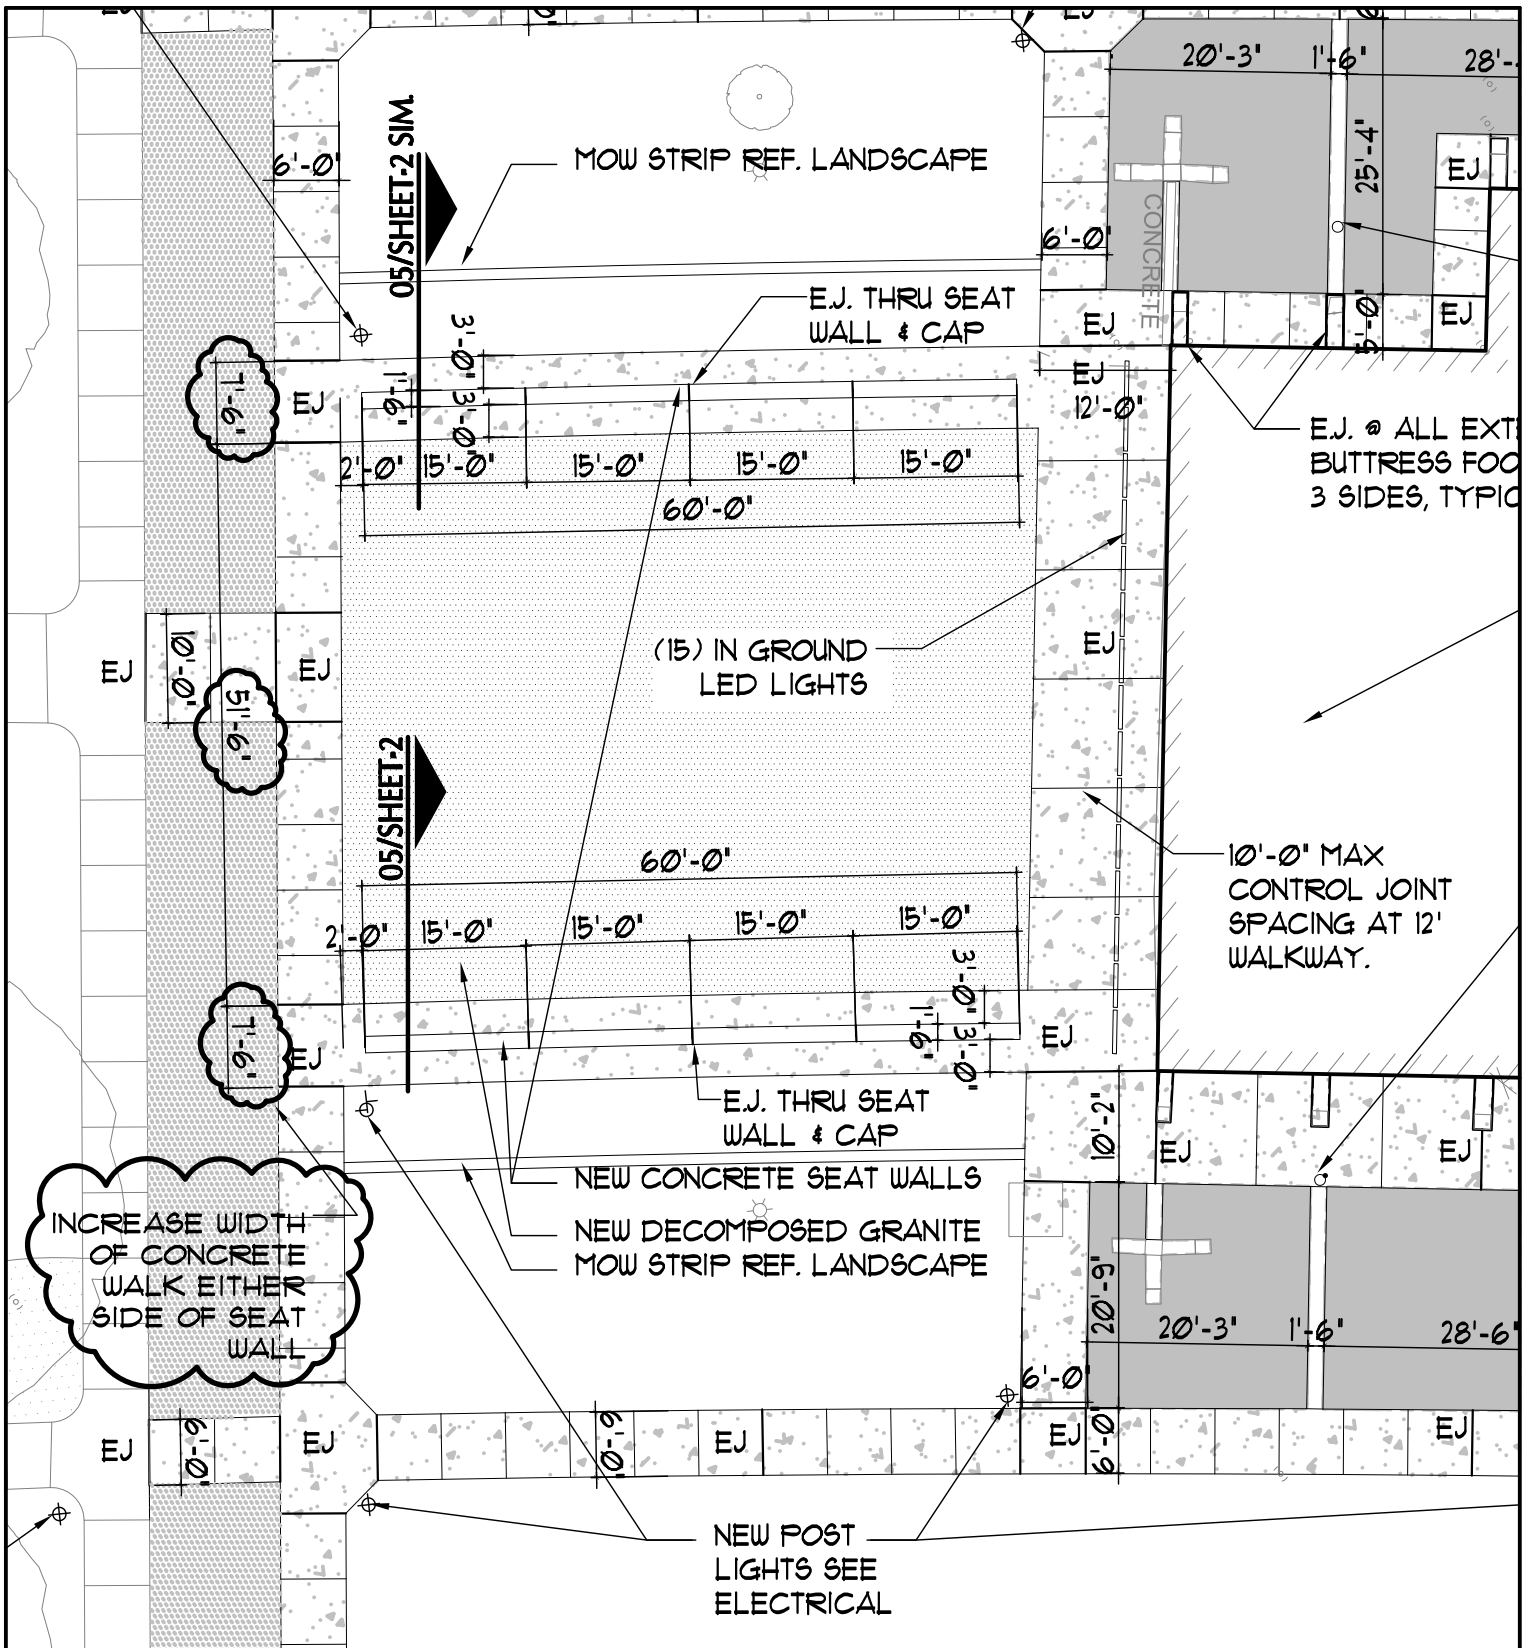


01 ENLARGED SITE PLAN
 SCALE N.T.S.

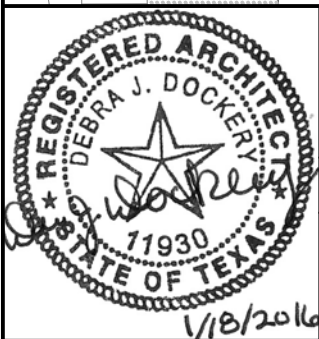 

REFERENCE: ADDENDUM #2	SHEET # 1 OF 2	DATE: 01-18-2016
HANGER 9 HISTORICAL RESTORATION	Debra J. Dockery, Architect, P.C.	
BROOKS CITY BASE PROJECT NO. 15-01	118 BROADWAY, SUITE 516 PHONE (210) 225-6130	SAN ANTONIO, TX 78205 FAX (210) 225-7588

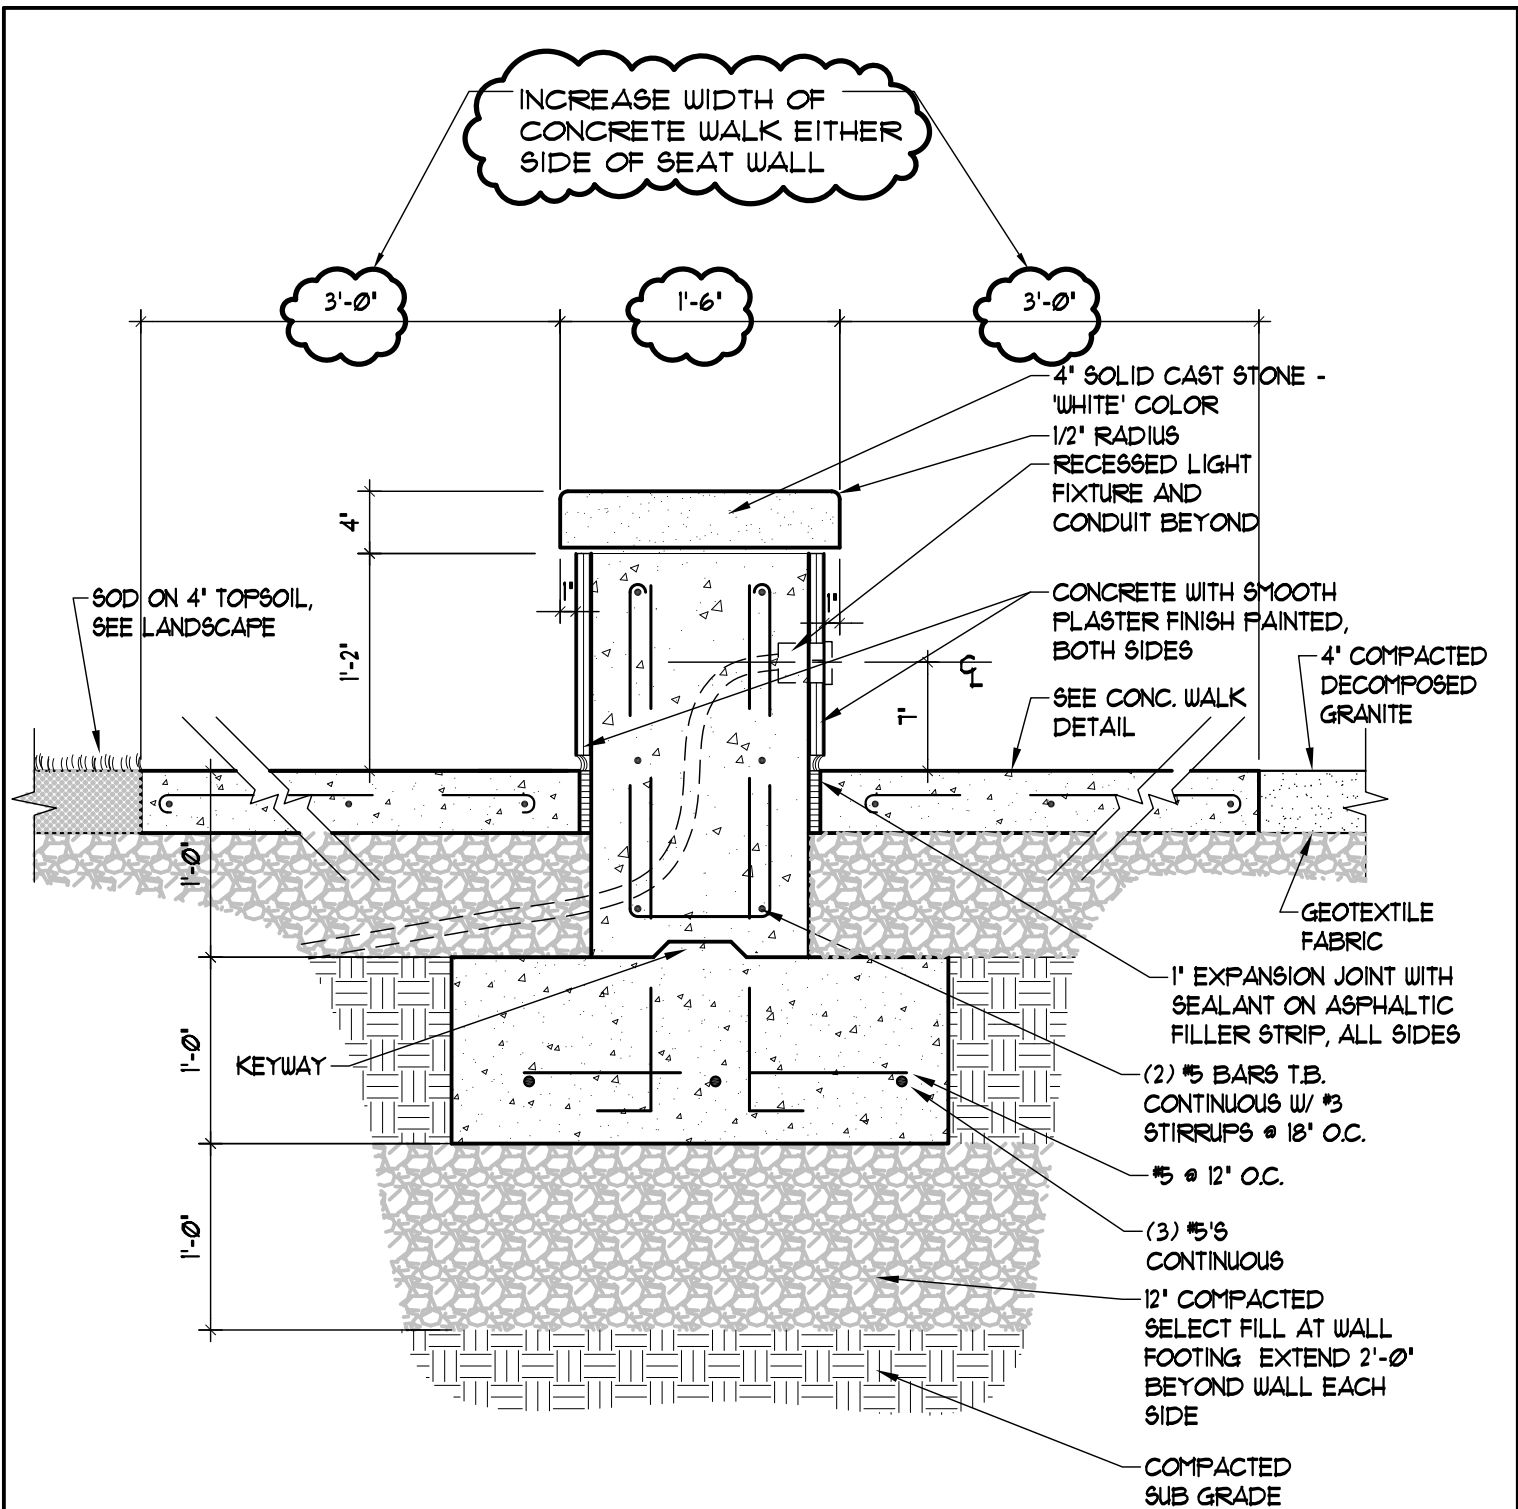

05 SEAT WALL / CONCRETE DETAIL
SCALE: 1"=1'-0"

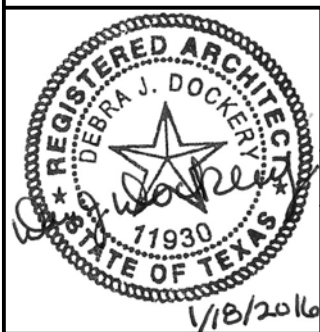

REFERENCE: ADDENDUM #2	SHEET # 2 OF 2	DATE: 01-18-2016
HANGER 9 HISTORICAL RESTORATION	Debra J. Dockery, Architect, P.C.	
BROOKS CITY BASE PROJECT NO. 15-01	118 BROADWAY, SUITE 516 PHONE (210) 225-6130	SAN ANTONIO, TX 78205 FAX (210) 225-7588