



TEXAS REGISTERED
ENGINEERING FIRM P-10487
700 N. ST. MARY'S
SUITE 1225
SAN ANTONIO, TX 78205
WWW.RGMENGINEERING.NET
PHONE: 210.299.4522
FAX: 210.299.4525

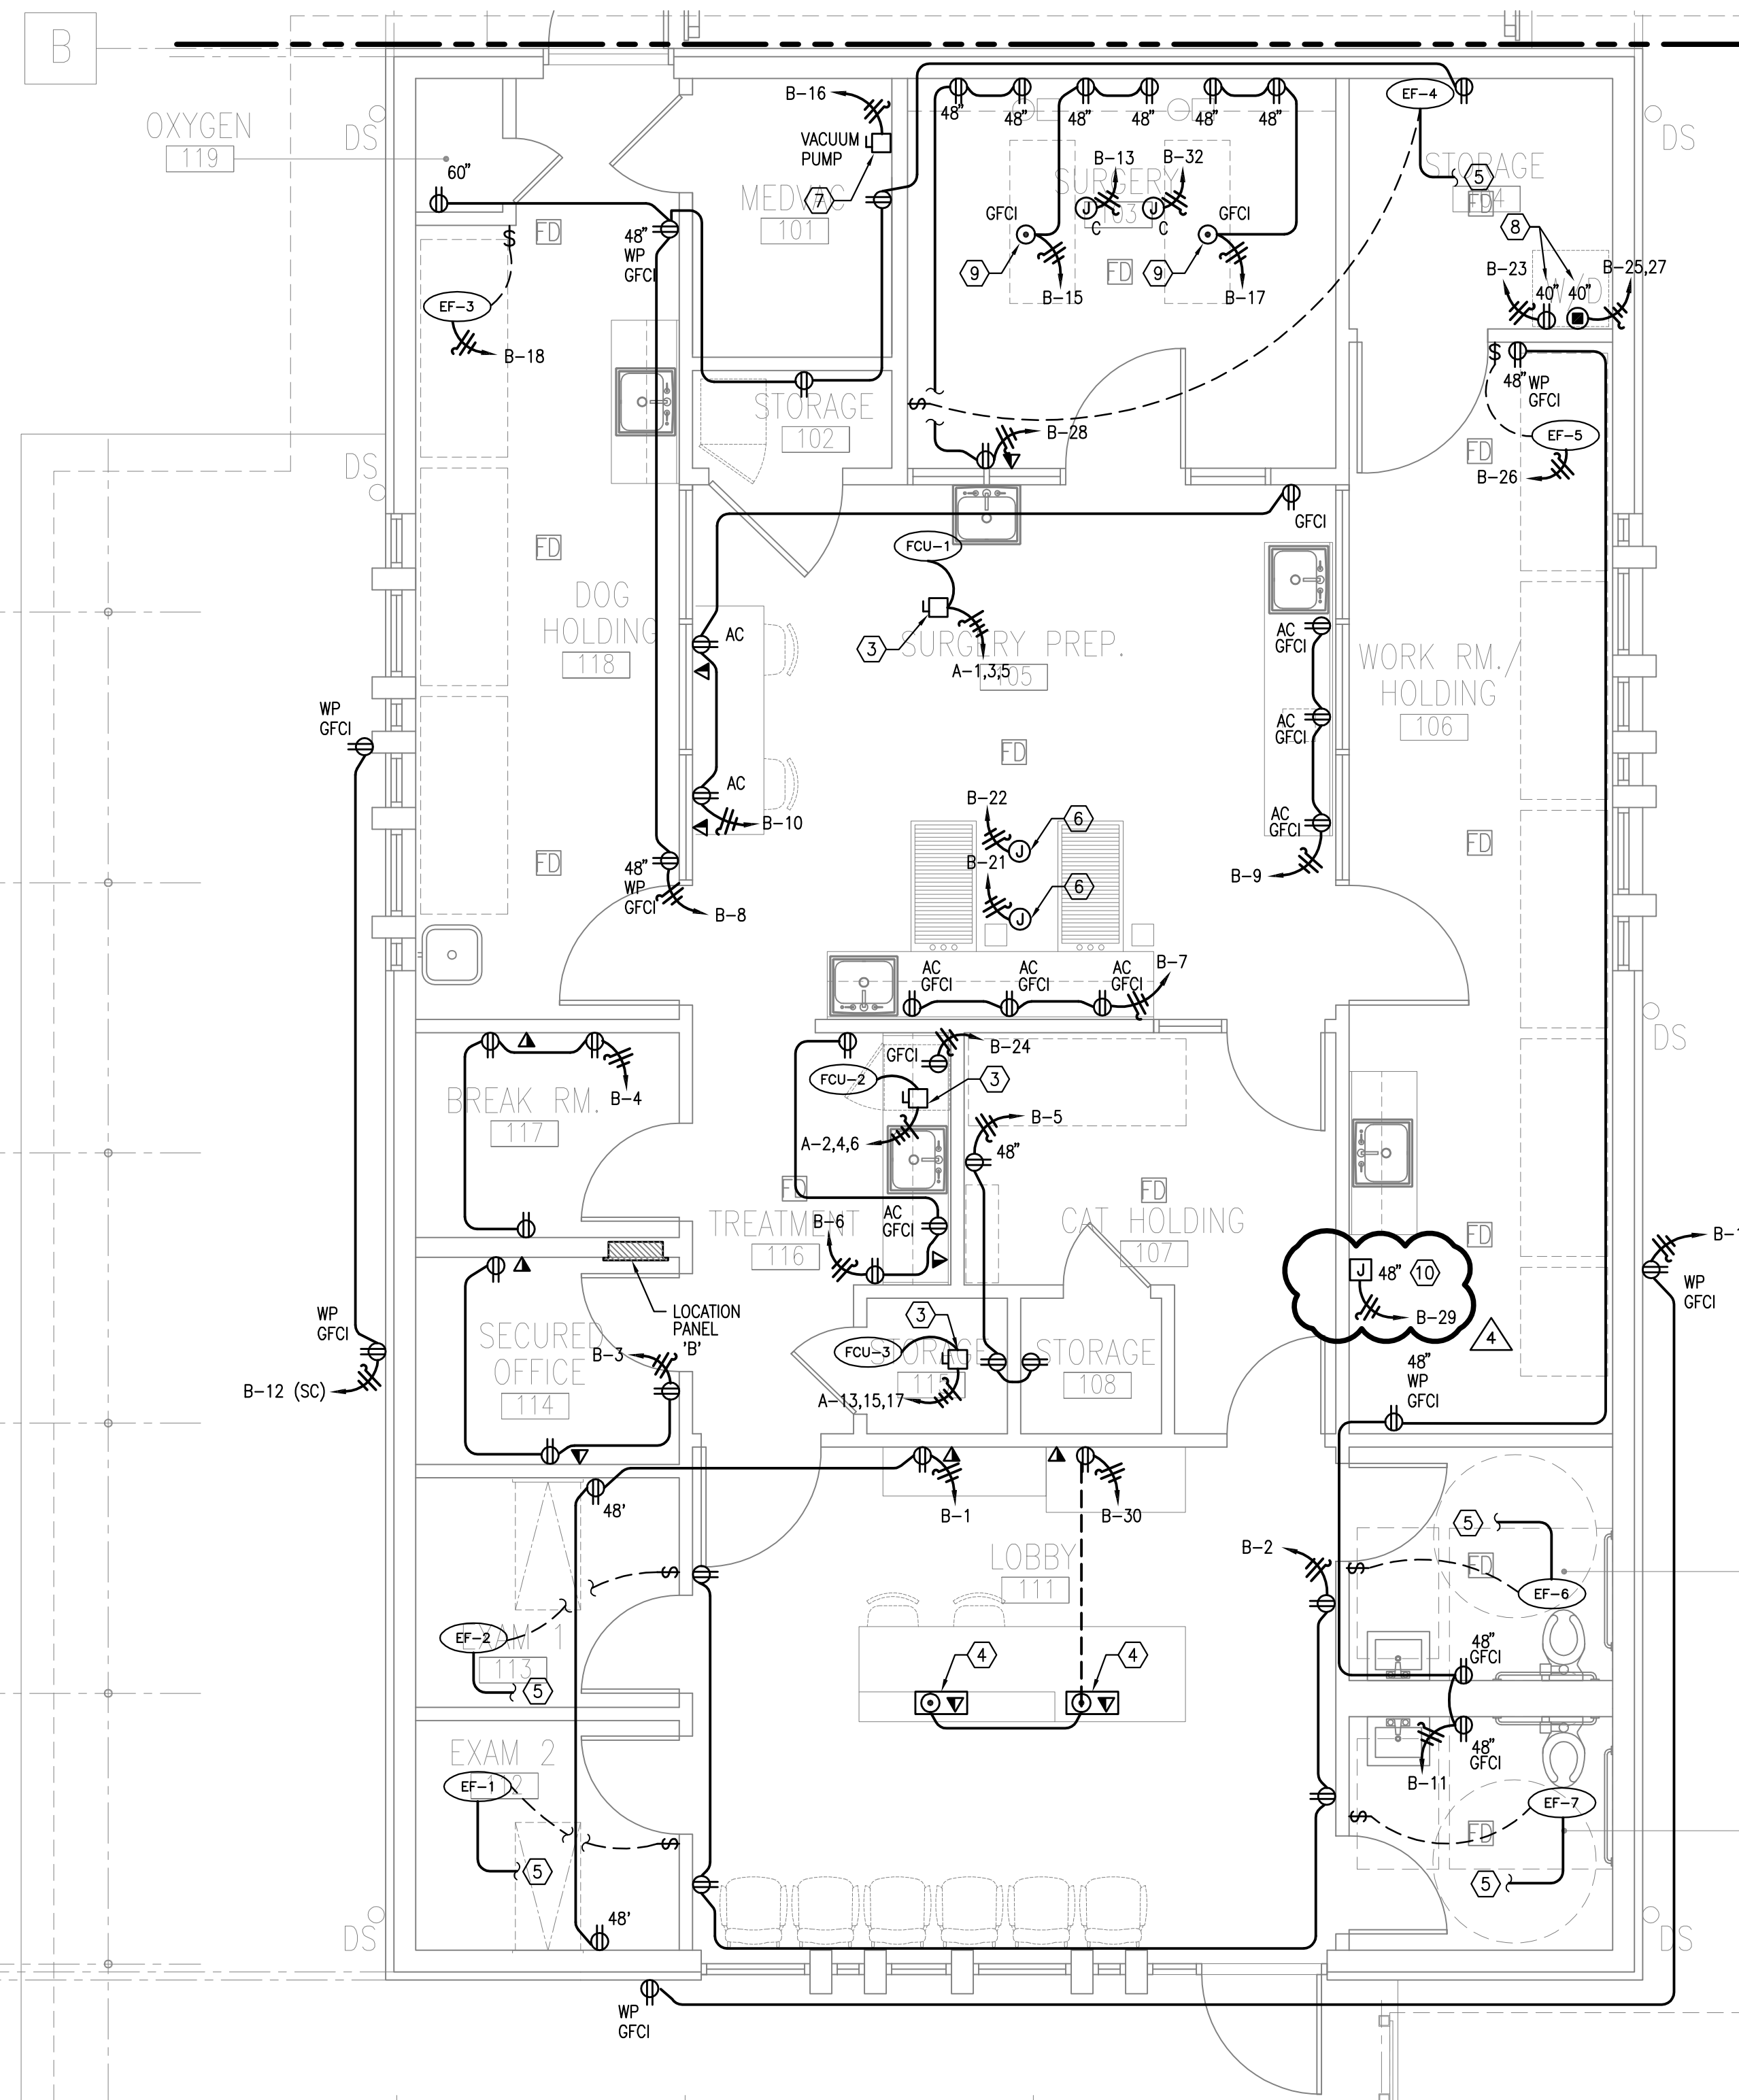

1 ELECTRICAL POWER FLOOR PLAN
SCALE: 1/4" = 1'-0"

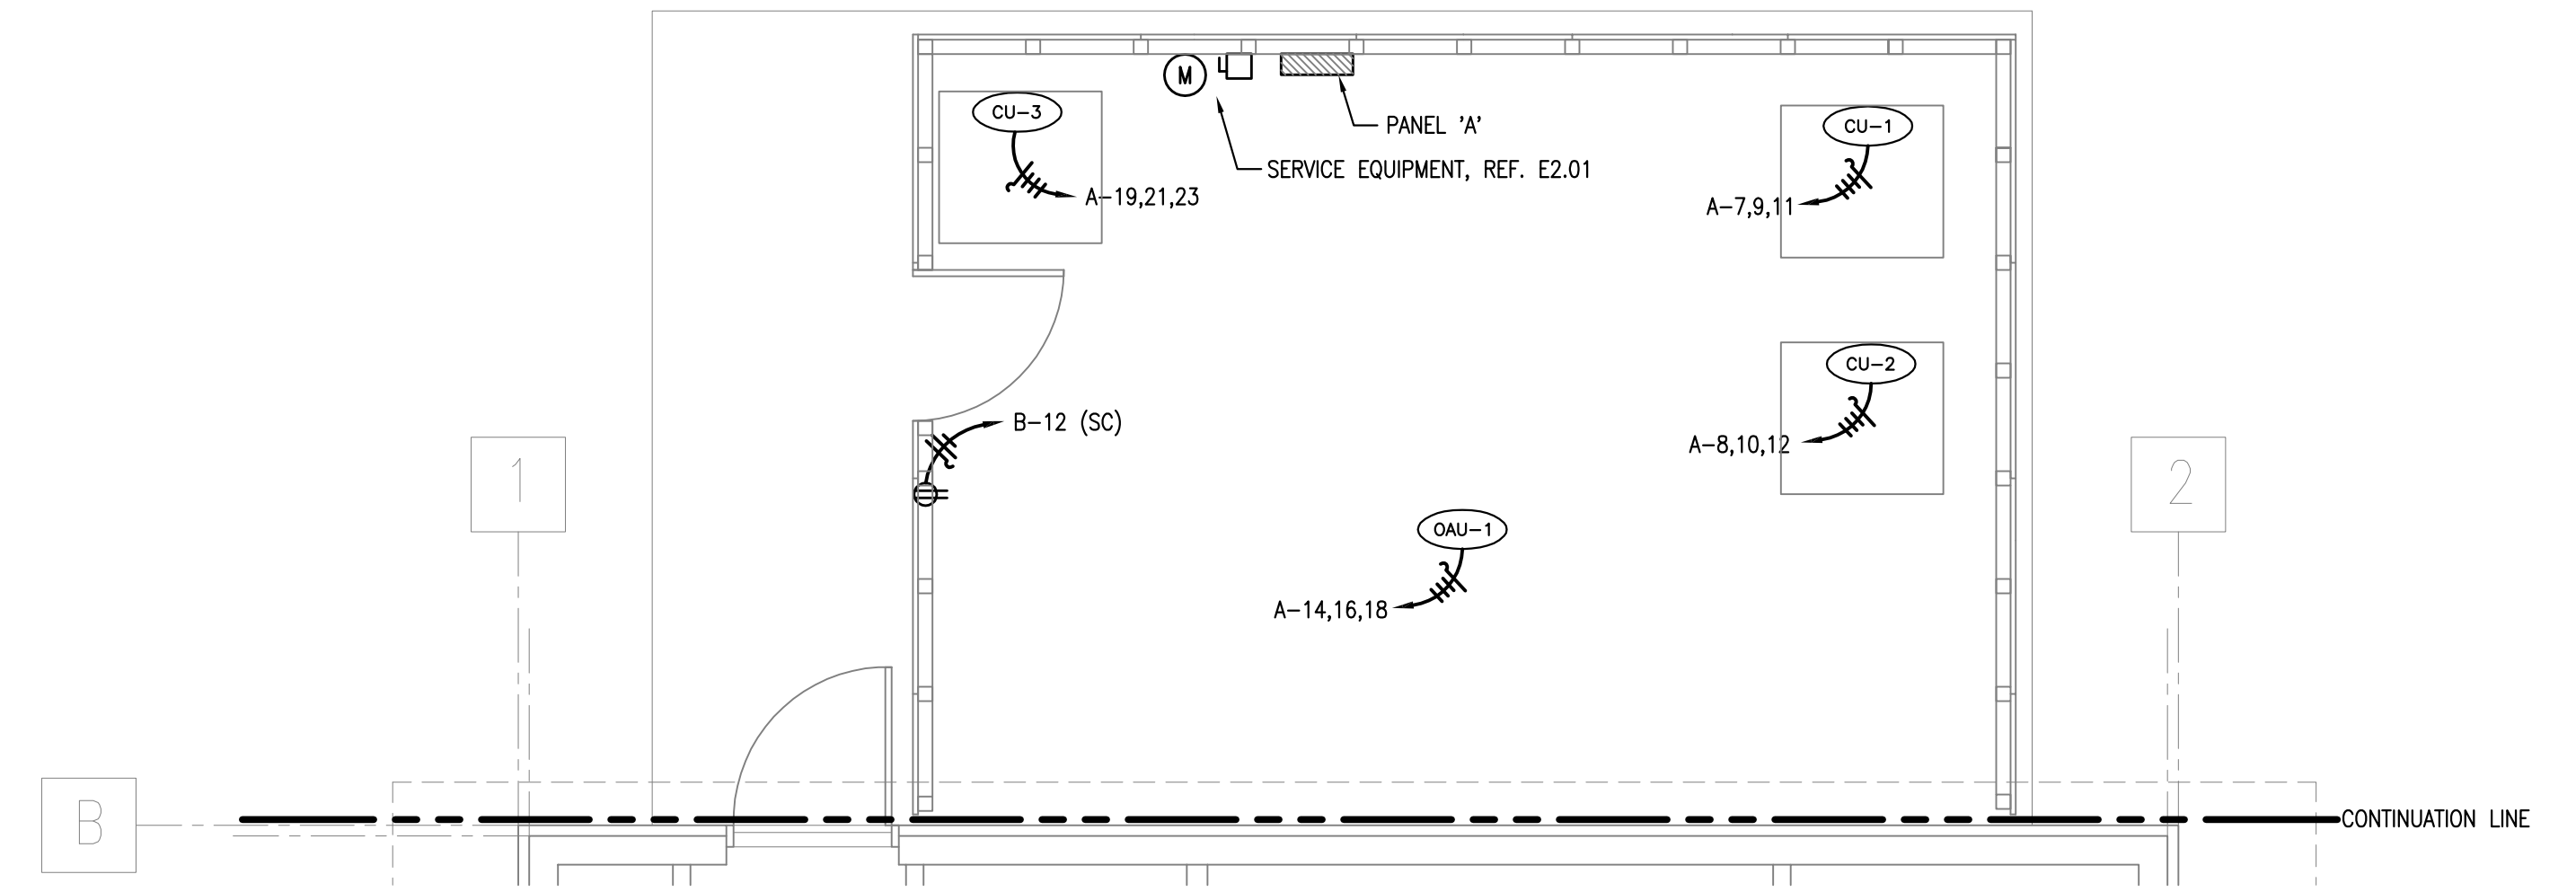

2 ELECTRICAL EQUIPMENT YARD
SCALE: 1/4" = 1'-0"

POWER KEYED NOTES:

- ① 30A/NF/3P/N3R
- ② 200A/NF/3P/N3R
- ③ 30A/NF/3P/N1
- ④ DUAL-SERVICE DATA/POWER, CONCRETE FLOOR BOX, WIREMOLD #RPSFB-OG WITH #RPCCTCBS BRASS COVER KIT.
- ⑤ CONNECT TO LIGHTING CIRCUIT.
- ⑥ COORDINATE LOCATION WITH SURGICAL LIGHT INSTALLER.
- ⑦ COORDINATE WITH VACUUM PUMP SUPPLIER.
- ⑧ COORDINATE LOCATION WITH WASHER/DRYER LAYOUT PER ARCHITECT.
- ⑨ SINGLE SERVICE CONCRETE FLOOR BOX, EQUAL TO #4 ABOVE. ARCHITECT
- ⑩ SOLIDS LEVEL CONTROL MODEL #10-CP-ZTR-A (SSD) REF. TO PARK SPECIFICATIONS DRAWING #CSD-CP-ZTR-A FOR INSTALLATION.

FILE NAME: 15-120 E.102 Electrical Power Floor Plan.dwg
 FILE LOCATION: N:\2015\15-120 Spry & Neider Clinic San Antonio\Electrical
 DATE: Wed, 06 Jan 2016 - 1:04pm
 PLOTTED BY: JosephH

ARCHITECT
DOUGLAS ARCHITECTS
1320 E. Houston St. Suite 102
San Antonio, TX 78205
T: 210.226.5500
F: 210.226.5501
www.douglasarchitects.net
Project No.: 1414
Project Architect: Andrew Douglas, AIA
Project Manager: Caleb Goins

OWNER
BROOKS CITY BASE
Contact: Jaime Lawhn
3201 Sidney Brooks
San Antonio, TX 78235
T: 210.678.3357
E: jaime.lawhn@brookscity-base.com
STRUCTURAL ENGINEER
LUNDY & FRANKE ENGINEERING, INC.
Contact: Duncan McAda
549 Helmer Rd.
San Antonio, TX 78232
T: 210.979.7900
E: mcada@lundyfranke.com

M.E.P. ENGINEER
R.G.M. ENGINEERING
Contact: Roger Mendez
700 N. St. Mary's, Suite 1225
San Antonio, TX 78205
T: 210.299.4522
E: roger@rgmengineering.net

SEAL
THE SEAL APPEARING ON THIS DOCUMENT WAS AUTHORIZED BY
ROGER G. MENDEZ, P.E., 93809
ON 01/05/2016

DATE	ISSUANCE
1	October 19, 2015 50% Progress Set
2	December 04, 2015 90% Progress Set
3	December 11, 2015 100% CD Set
4	December 15, 2015 Addendum 1
5	December 16, 2015 Addendum 2
6	December 22, 2015 Addendum 3
7	January 05, 2016 Addendum 4

PROJECT
VETERINARY CLINIC AT BROOKS
ADDENDUM 4
JANUARY 05, 2016

SHEET NAME
ELECTRICAL POWER FLOOR PLAN
SHEET NUMBER
E1.02