



CAD	P
JH/RAH/HG	HN
E	MC
M	TP
PM	RCM

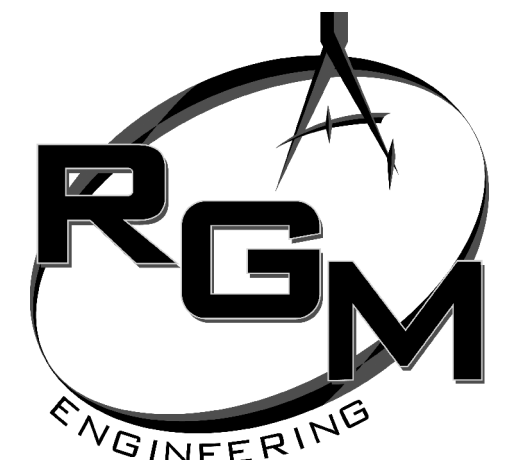


TEXAS REGISTERED  
ENGINEERING FIRM P-10487  
700 N. ST. MARY'S  
SUITE 1225  
SAN ANTONIO, TX 78205  
WWW.RGMENGINEERING.NET  
PHONE: 210.299.4522  
FAX: 210.299.4525

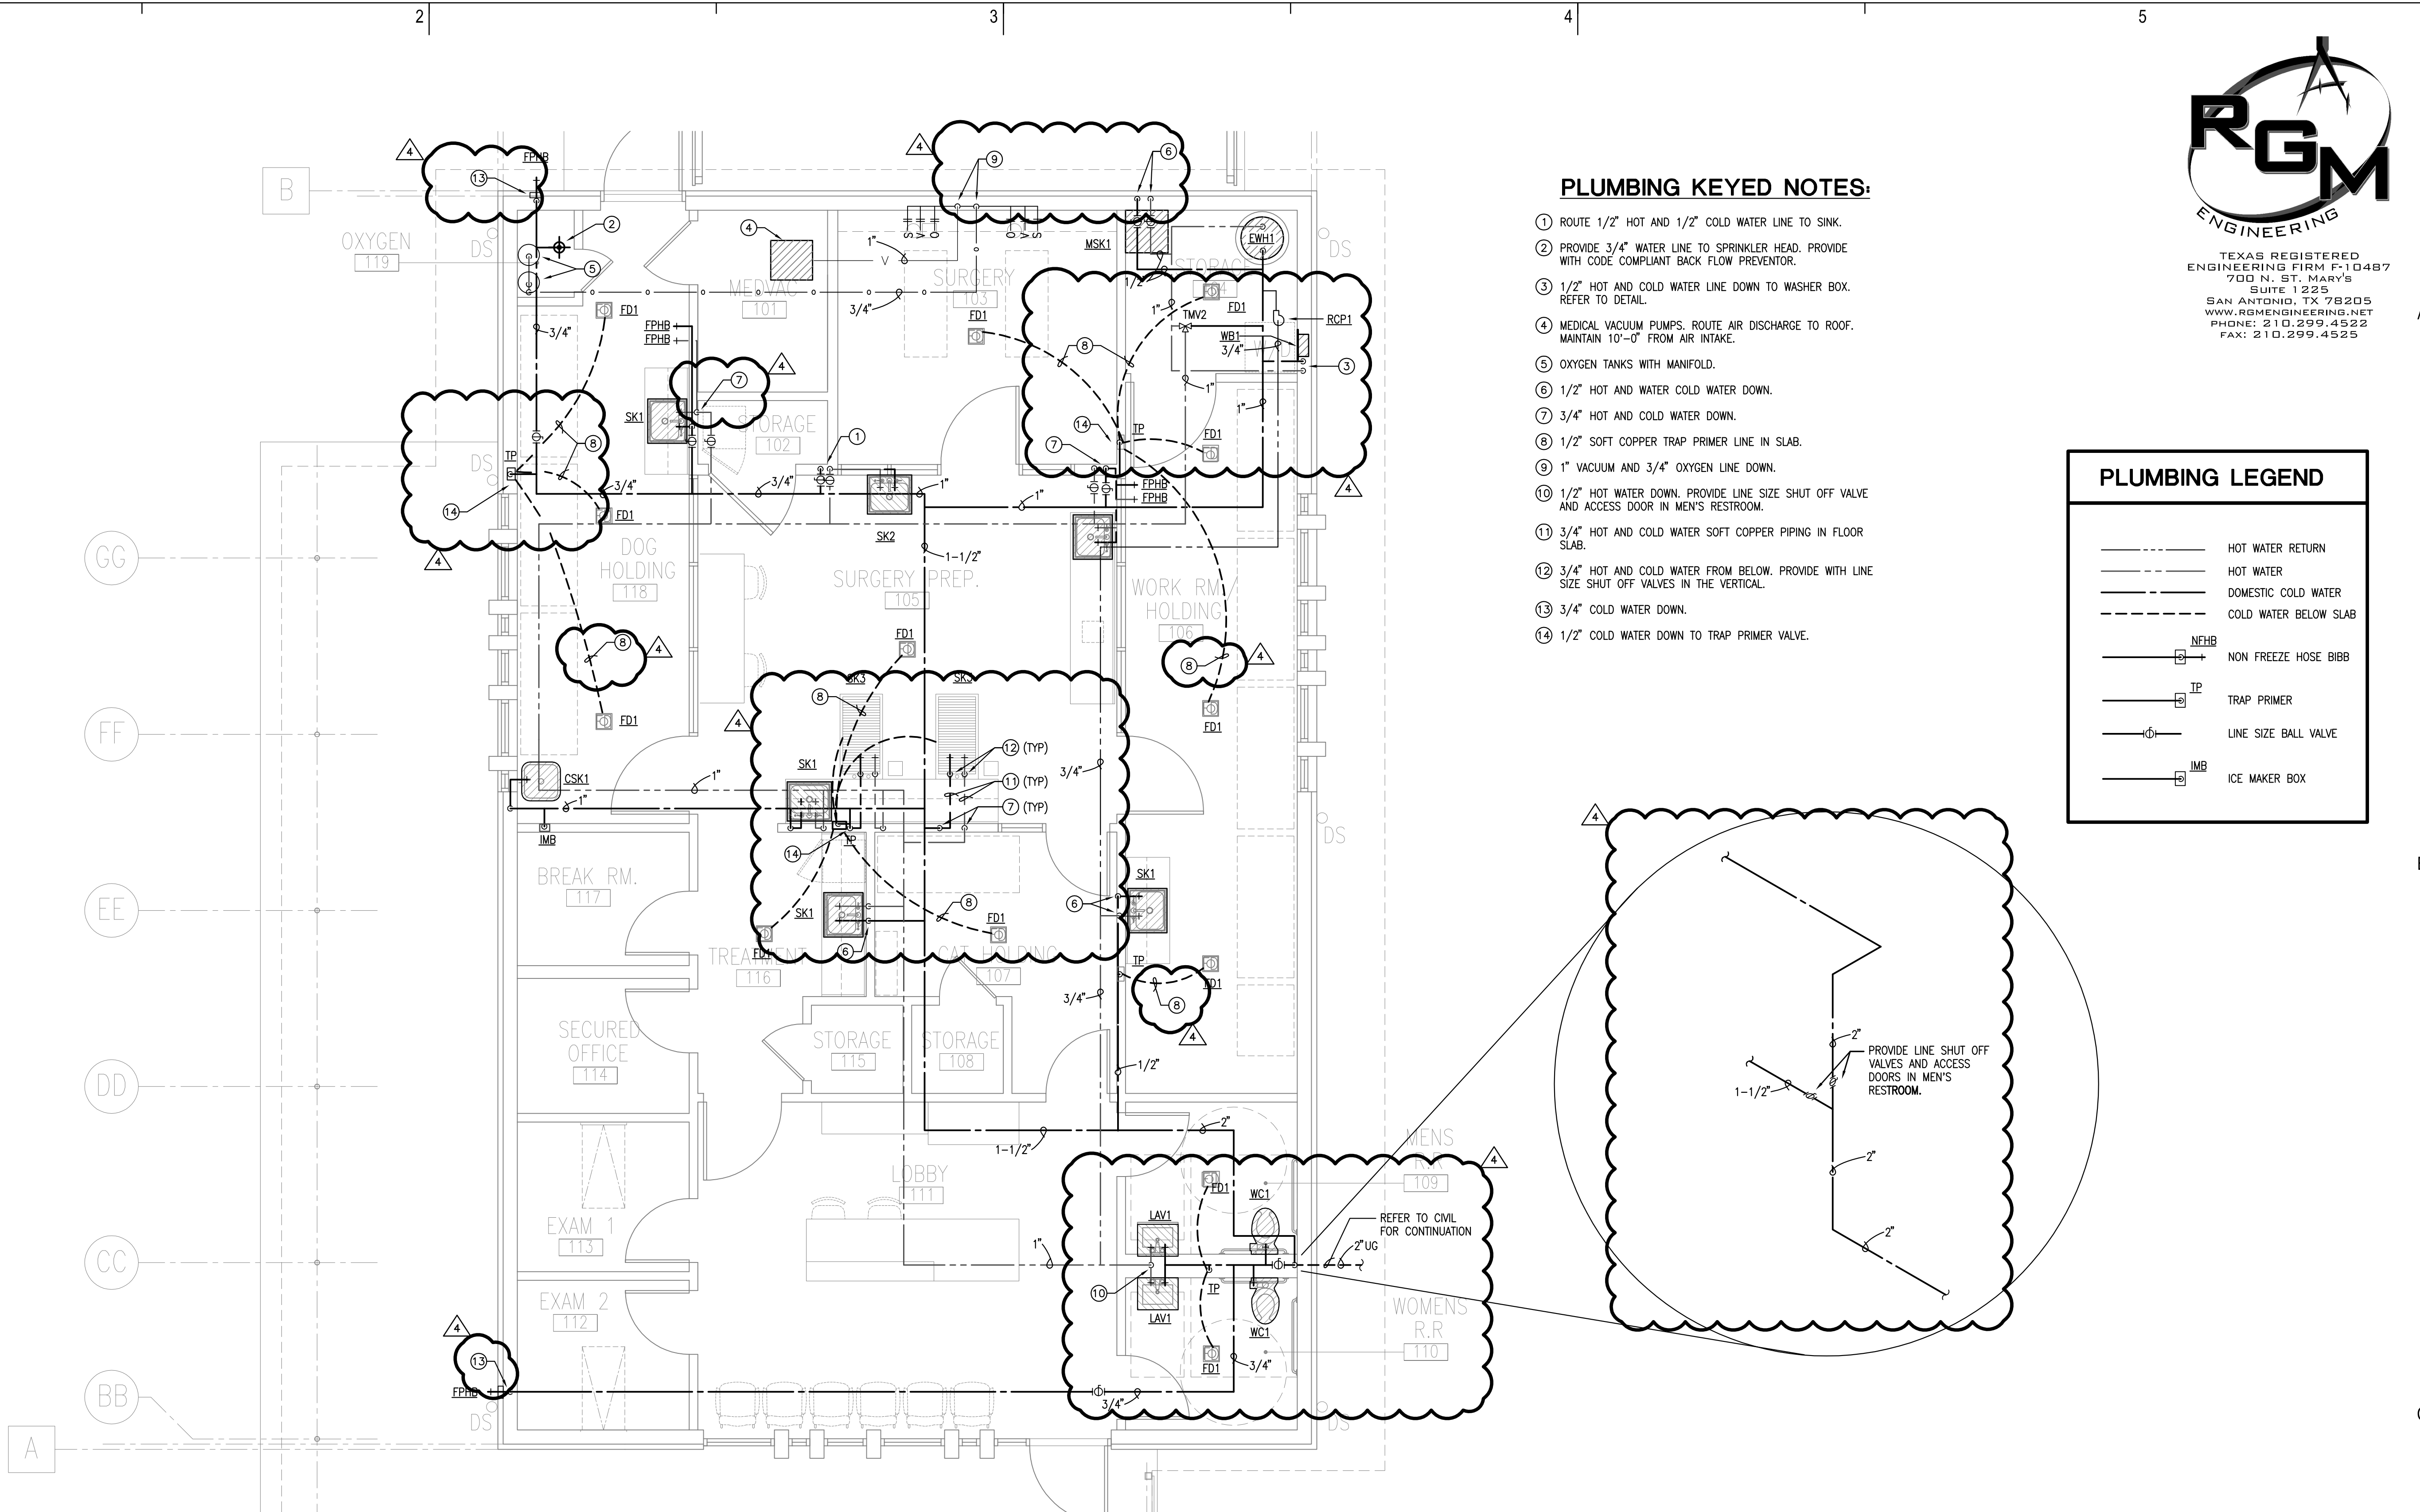

**PLUMBING KEYED NOTES:**

- ① ROUTE 1/2" HOT AND 1/2" COLD WATER LINE TO SINK.
- ② PROVIDE 3/4" WATER LINE TO SPRINKLER HEAD. PROVIDE WITH CODE COMPLIANT BACK FLOW PREVENTOR.
- ③ 1/2" HOT AND COLD WATER LINE DOWN TO WASHER BOX. REFER TO DETAIL.
- ④ MEDICAL VACUUM PUMPS. ROUTE AIR DISCHARGE TO ROOF. MAINTAIN 10'-0" FROM AIR INTAKE.
- ⑤ OXYGEN TANKS WITH MANIFOLD.
- ⑥ 1/2" HOT AND WATER COLD WATER DOWN.
- ⑦ 3/4" HOT AND COLD WATER DOWN.
- ⑧ 1/2" SOFT COPPER TRAP PRIMER LINE IN SLAB.
- ⑨ 1" VACUUM AND 3/4" OXYGEN LINE DOWN.
- ⑩ 1/2" HOT WATER DOWN. PROVIDE LINE SIZE SHUT OFF VALVE AND ACCESS DOOR IN MEN'S RESTROOM.
- ⑪ 3/4" HOT AND COLD WATER SOFT COPPER PIPING IN FLOOR SLAB.
- ⑫ 3/4" HOT AND COLD WATER FROM BELOW. PROVIDE WITH LINE SIZE SHUT OFF VALVES IN THE VERTICAL.
- ⑬ 3/4" COLD WATER DOWN.
- ⑭ 1/2" COLD WATER DOWN TO TRAP PRIMER VALVE.

**PLUMBING LEGEND**

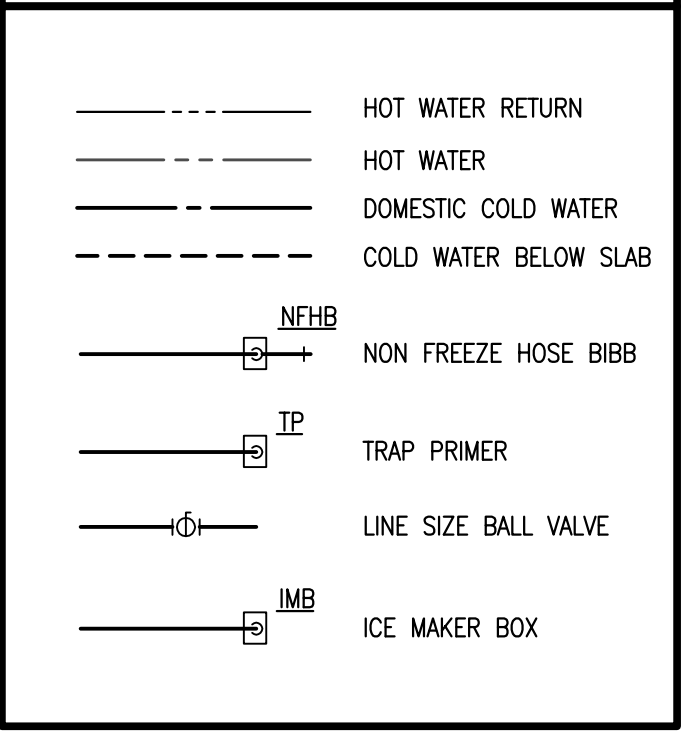


**1 PLUMBING DOMESTIC WATER AND MEDICAL GAS FLOOR PLAN**  
SCALE: 1/4" = 1'-0"

FILE NAME: 15-120 F1.02 Plumbing Domestic Water - Med Gas Floor Plan.rvt  
FILE LOCATION: N:\2015\15-120 Spry & Neider Clinic San Antonio\Plumbing  
DATE: Wed, 06 Jan 2016 - 1:00pm  
PLOTTER: Joseph

**ARCHITECT**  
**DOUGLAS ARCHITECTS**  
1320 E. Houston St. Suite 102  
San Antonio, TX 78205  
T: 210.226.5500  
F: 210.226.5501  
www.douglasarchitects.net  
Project No.: 1414  
Project Architect: Andrew Douglas, AIA  
Project Manager: Caleb Goins

**OWNER**  
**BROOKS CITY BASE**  
Contact: Jaime Lawhn  
3201 Sidney Brooks  
San Antonio, TX 78235  
T: 210.678.3357  
E: jaime.lawhn@brookscity-base.com  
**STRUCTURAL ENGINEER**  
**LUNDY & FRANKE ENGINEERING, INC.**  
Contact: Duncan McAda  
549 Helmer Rd.  
San Antonio, TX 78232  
T: 210.979.7900  
E: mcada@lundyfranke.com

**M.E.P. ENGINEER**  
**R.G.M. ENGINEERING**  
Contact: Roger Mendez  
700 N. St. Mary's, Suite 1225  
San Antonio, TX 78205  
T: 210.299.4522  
E: roger@rgmengineering.net

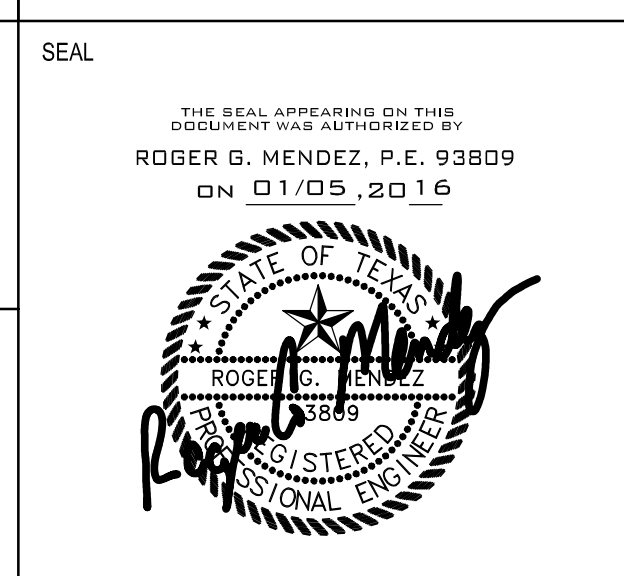

DATE	ISSUANCE
1	October 19, 2015 50% Progress Set
2	December 04, 2015 90% Progress Set
3	December 11, 2015 100% CD Set
4	December 15, 2015 Addendum 1
5	December 16, 2015 Addendum 2
6	December 22, 2015 Addendum 3
7	January 05, 2016 Addendum 4

**PROJECT**  
**VETERINARY CLINIC AT BROOKS**  
**PROJECT STATUS**  
**ADDENDUM 4**  
JANUARY 05, 2016

**SHEET NAME**  
**PLUMBING DOMESTIC WATER/ MEDICAL GAS FLOOR PLAN**  
**SHEET NUMBER**  
**P1.02**